


- KEYED NOTES:**
- (A) 1-1/2" PVC SCH40 WATER SERVICE LINE, 1" METER AND VALVE BOX. REFER TO PLUMBING PLANS OR CONNECTION REQUIREMENTS AT BUILDING.
 - (B) PROVIDE ALL CONDUITS AND WIRING FROM SERVICE POLE/METER TO BUILDING. CONTRACTOR IS TO COORDINATE WITH THE BUILDING MANUFACTURER (CTX) REQUIREMENTS AND CONNECT POWER TO THE PRE-INSTALLED 200 AMP SERVICE PANEL ON THE BUILDING.
 - (C) 4" PVC SEWER SERVICE LINE. REFER TO PLUMBING PLANS FOR CONNECTION REQUIREMENTS AT BUILDING.
 - (D) SMITH PUMP LDGS DUPLEX PACKAGE WETWELL AND LIFTSTATION.
 - (E) 2" PVC SEWER FORCEMAIN. REFER TO C3.2.
 - (F) LIGHT POLE.
 - (G) PROVIDE ALL CONDUITS AND WIRING FROM SERVICE POLE/METER TO LIFTSTATION CONTROL PANEL. CONTRACTOR IS TO COORDINATE WITH THE LIFTSTATION MANUFACTURER TO PROVIDE APPROPRIATE WIRING.

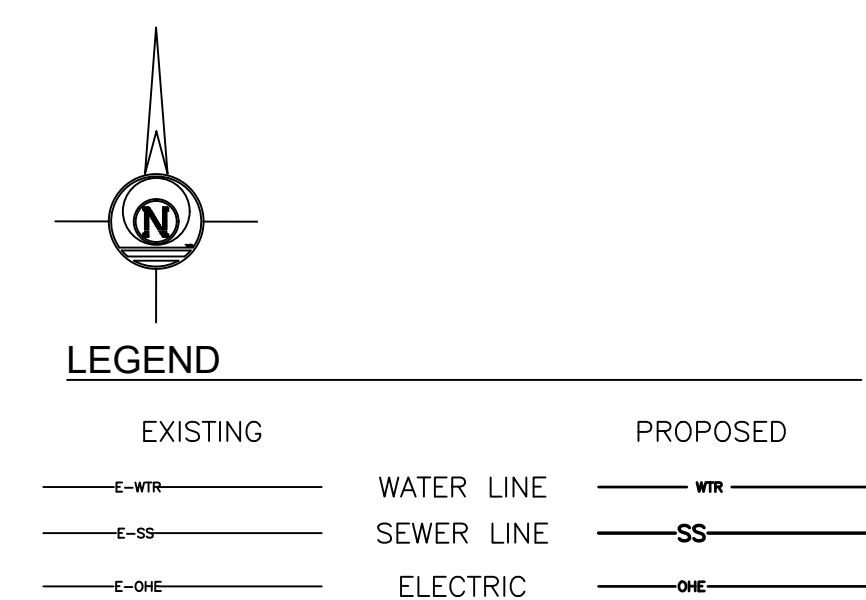

- UTILITY NOTES:**
1. ALL WORK SHALL BE PERFORMED IN ACCORDANCE WITH THE CITY OF SAN ANGELO PUBLIC WORKS STANDARDS, APPLICABLE CODES, AND THE PROJECT SPECIFICATIONS. THE MORE STRINGENT STANDARD SHALL APPLY WHEN IN CONFLICT.
- APPLICABLE CODES:
 2015 INTERNATIONAL BUILDING CODE
 2014 NATIONAL ELECTRICAL CODE
 2015 INTERNATIONAL PLUMBING CODE
 2015 INTERNATIONAL MECHANICAL CODE
 CITY OF SAN ANGELO ORDINANCES
2. EXISTING LINE LOCATIONS ARE SHOWN FOR THE CONVENIENCE OF THE CONTRACTOR IN ACCORDANCE WITH THE BEST INFORMATION AVAILABLE, BUT IS NOT GUARANTEED TO BE CORRECT OR COMPLETE.
 3. THE CONTRACTOR IS RESPONSIBLE FOR VERIFYING THE EXACT SIZE, TYPE, AND LOCATION OF ALL UTILITIES AND PROTECTING AND REPAIRING THE SAME AT NO ADDITIONAL COST TO THE OWNER.
 4. COORDINATE WITH THE ARCHITECTURAL, STRUCTURAL, MECHANICAL, PLUMBING, AND ELECTRICAL DRAWINGS AND VERIFY THE LOCATION OF ALL PROJECT REQUIREMENTS.
 5. PROVIDE WATER SERVICE FROM EXISTING MAIN TO BUILDING. CONTACT THE CITY OF SAN ANGELO WATER UTILITY DEPT. AT 325.657.4209 FOR CHARGES OR FEES FOR WATER SERVICE CONNECTION. METERS AND VALVE BOXES TO BE FLUSH WITH GRADE. ALL WORK SHALL MEET THE REQUIREMENTS OF AND SHALL BE INSPECTED BY THE CITY OF SAN ANGELO.
 6. PROVIDE NEW SEWER SERVICE FROM EXISTING MAIN TO BUILDING. CONTACT THE CITY OF SAN ANGELO WATER UTILITY DEPT. AT 325.657.4209 FOR CHARGES OR FEES FOR SEWER SERVICE CONNECTION. ALL WORK SHALL MEET THE REQUIREMENTS OF AND SHALL BE INSPECTED BY THE CITY OF SAN ANGELO.
 7. PROVIDE ELECTRICAL SERVICE TO BUILDING. VERIFY ELECTRICAL SERVICE REQUIREMENTS WITH AEP. CONTACT AEP FOR CHARGES, FEES, AND INSTALLATION REQUIREMENTS FOR ELECTRICAL SERVICE. CONTRACTOR IS RESPONSIBLE FOR MOUNTING METER BASE, METER, DITCHING, & ALL CONDUITS.

SKG ENGINEERING
 SURVEYING • LABORATORY • ENVIRONMENTAL
 706 SOUTH ABE STREET
 SAN ANGELO, TEXAS 76903
 PHONE: 325.657.1288
 FAX: 325.657.8188
 FIRM REGISTRATION NUMBER F-7608
 www.skg.com

STATE OF TEXAS
 RUSSELL T. GULLY
 87727
 LICENSED PROFESSIONAL ENGINEER
 THE SEAL APPEARING ON THIS DRAWING WAS AUTHORIZED BY RUSSELL T. GULLY, P.E. 87727 SKG ENGINEERING, LLC #F-7608



**MIDDLE CONCHO BOAT RAMP IMPROVEMENTS
 MIDDLE CONCHO PARK
 SAN ANGELO, TEXAS**

UTILITY PLAN

REVISIONS

5-14-2020	Addendum #1

DWG BY: RTG DWG DATE: FEB. 6, 2020
 JOB NO: 19-E-0890 SHEET NO:
 SCALE: 1"=20' **C3.1**

80 GRAPHIC SCALE 40 20 10 0 FEET