



CONSTRUCTION MANAGEMENT
DEPARTMENT
52 W. COLLEGE AVE.
SAN ANGELO, TEXAS 76903
PHONE: 325-657-4239
alfonso.lorres@cosatx.us

NEIGHBORHOOD & FAMILY SERVICES
NEW FAMILY HOME
1220 E. 24TH STREET
SAN ANGELO, TEXAS




JOB #:
DATE: 5/18/20
DRAWN BY:
CHECKED BY:
REVISIONS:

FOR REVIEW

SHEET NO.

A1.0

OF SHEETS

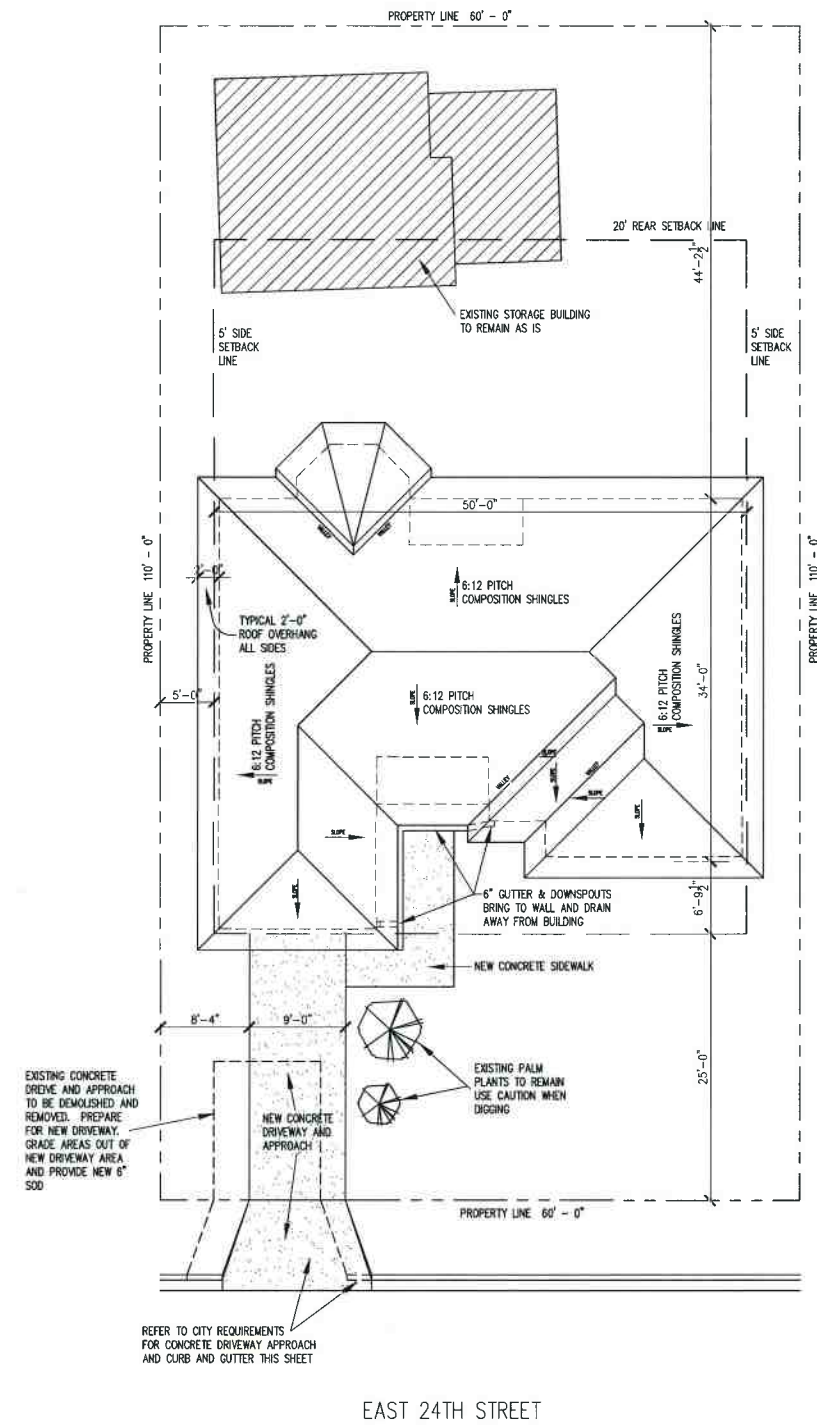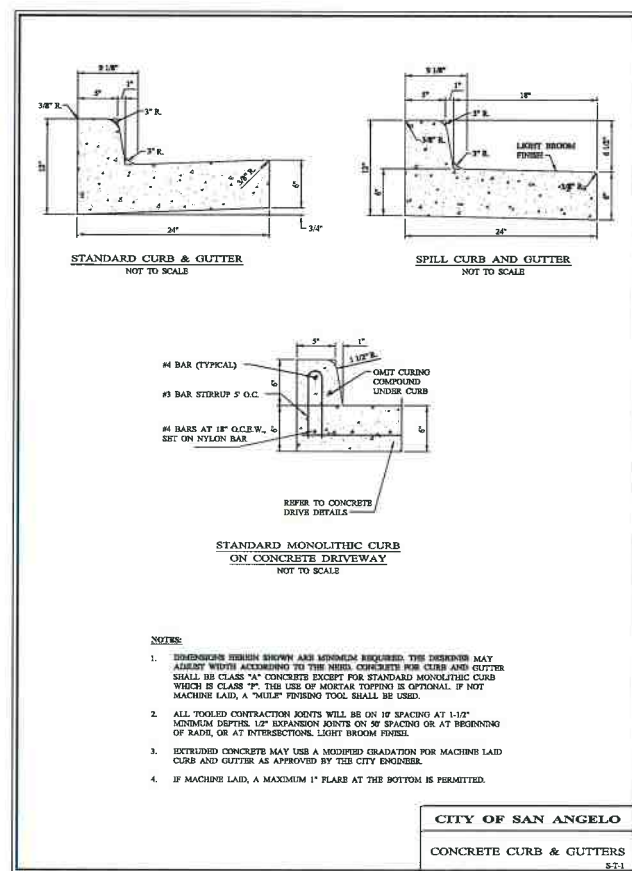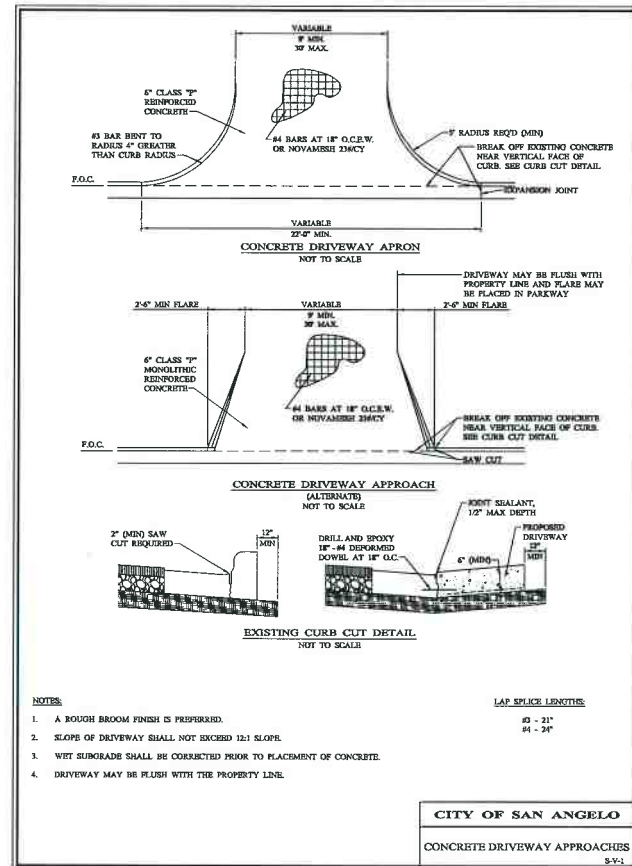

A SITE PLAN
SCALE: 1/8" = 1'-0"




LOT SQUARE FOOTAGE: 60' X 110' = 6,600 SQUARE FEET
40% LOT COVERAGE ALLOWED: 2,640 SQUARE FEET


TOTAL SQUARE FOOTAGE: 1,709 SQUARE FEET
RESIDENCE: 1,295 SQUARE FEET
EXISTING STORAGE BLDG & CANOPY: 414 SQUARE FEET




CONSTRUCTION MANAGEMENT
DEPARTMENT
52 W. COLLEGE AVE.
SAN ANGELO, TEXAS 76903
PHONE: 325-657-4239
info@cityofsanangelo.com

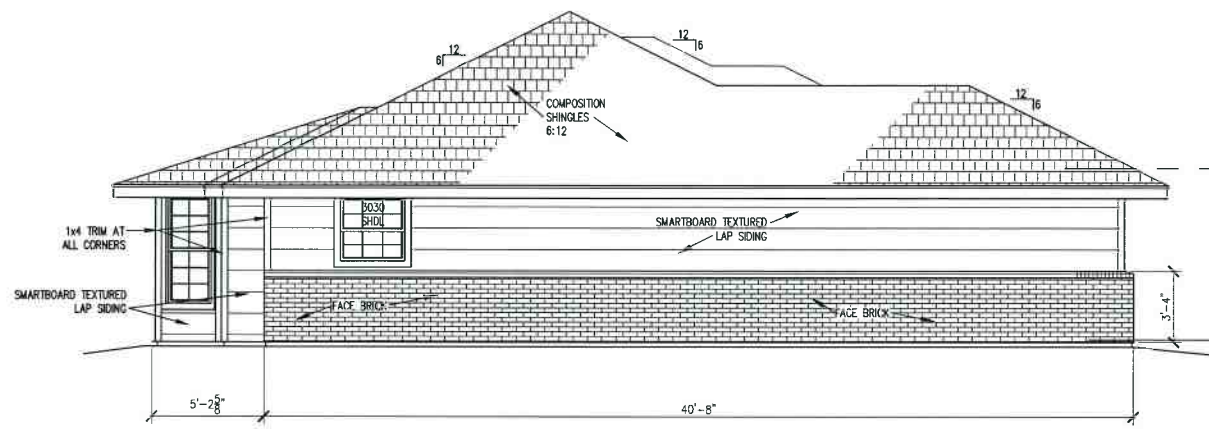


A WEST ELEVATION
SCALE: 1/4" = 1'-0"

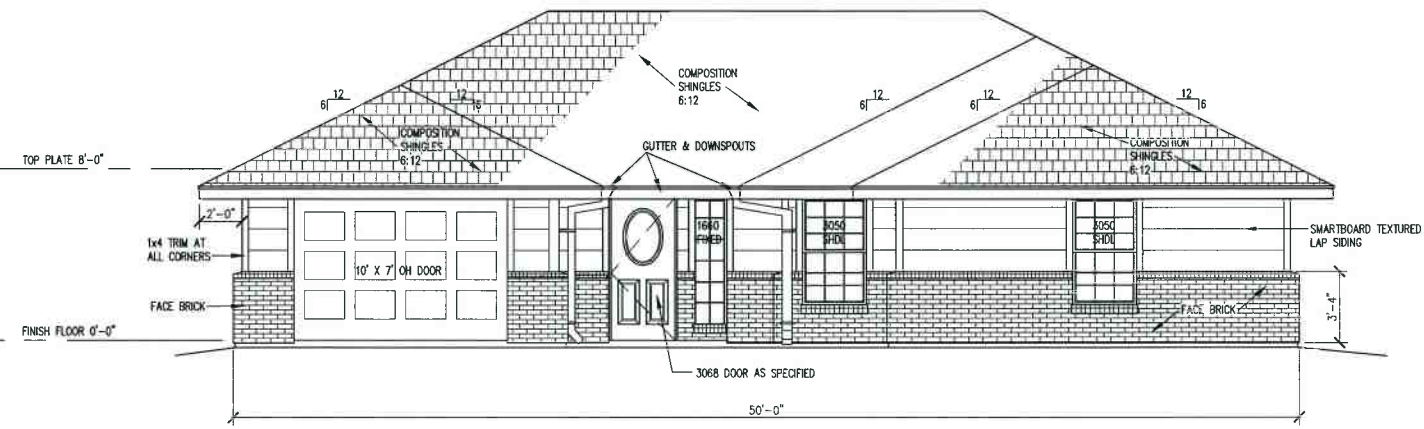

B SOUTH ELEVATION
SCALE: 1/4" = 1'-0"

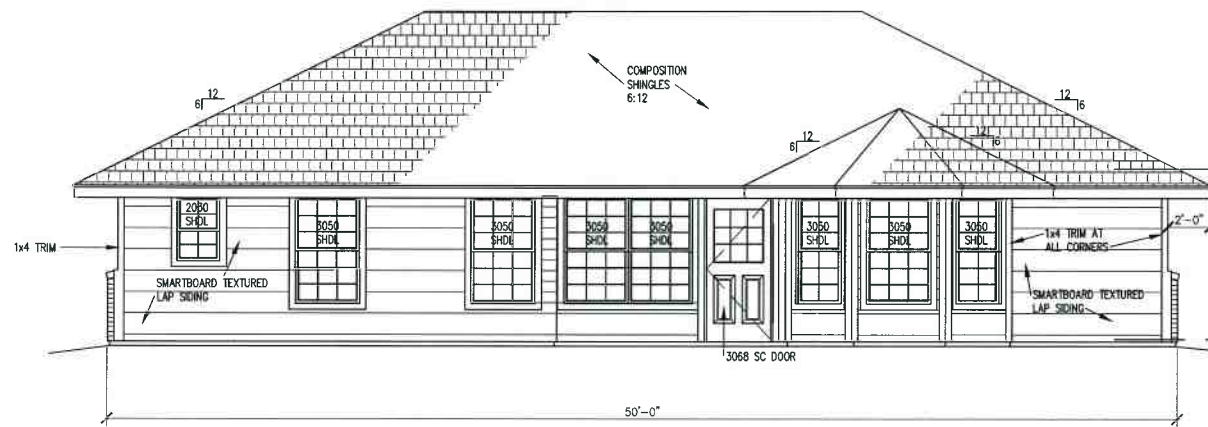

C NORTH ELEVATION
SCALE: 1/4" = 1'-0"

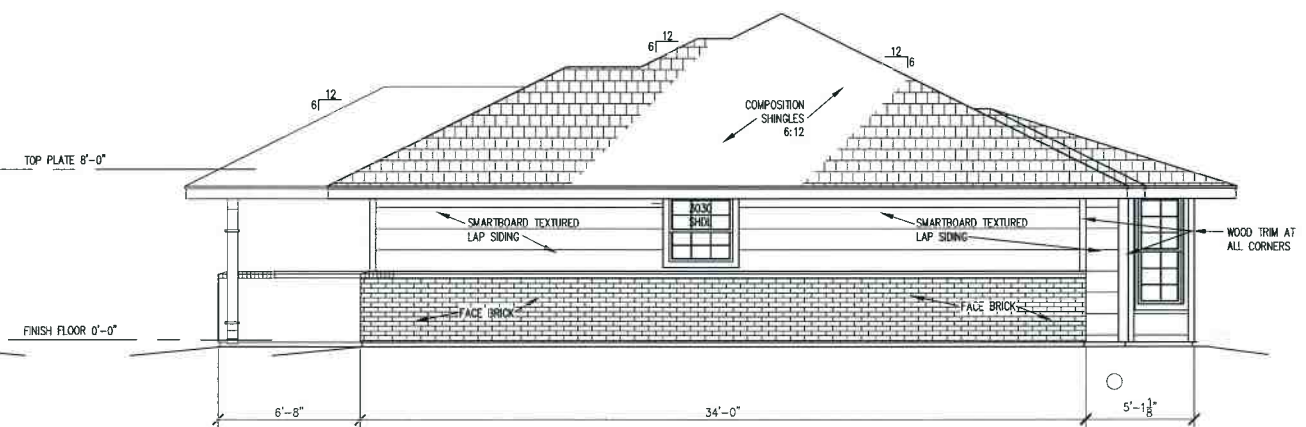

D EAST ELEVATION
SCALE: 1/4" = 1'-0"

FORMAT: 24 X 36 SCALE: 1/8"

NEIGHBORHOOD & FAMILY SERVICES
NEW FAMILY HOME
1220 E. 24TH STREET
SAN ANGELO, TEXAS

JOB #:
DATE: 5/18/20
DRAWN BY:
CHECKED BY:
REVISIONS:

FOR REVIEW

SHEET NO.












 
A3.0


OF SHEETS



CONSTRUCTION MANAGEMENT
DEPARTMENT
52 W. COLLEGE AVE.
SAN ANGELO, TEXAS 76903
PHONE: 325-657-4239
alfonso.torres@coesa.tx.us

LEGEND

-  COMB LITE/HEAT/EXHAUST
-  SMOKE DETECTOR
-  SMOKE DETECTOR AND CARBON MONOXIDE DETECTOR COMBO
-  3 WAY SWITCH
-  SWITCH
-  LIGHT KIT
-  110v OUTLET
-  220v OUTLET
-  GROUND FAULT CIRCUIT INTERRUPTER OUTLET
-  TELEPHONE OUTLET
-  CABLE TV OUTLET
-  CEILING FAN WITH LIGHT KIT

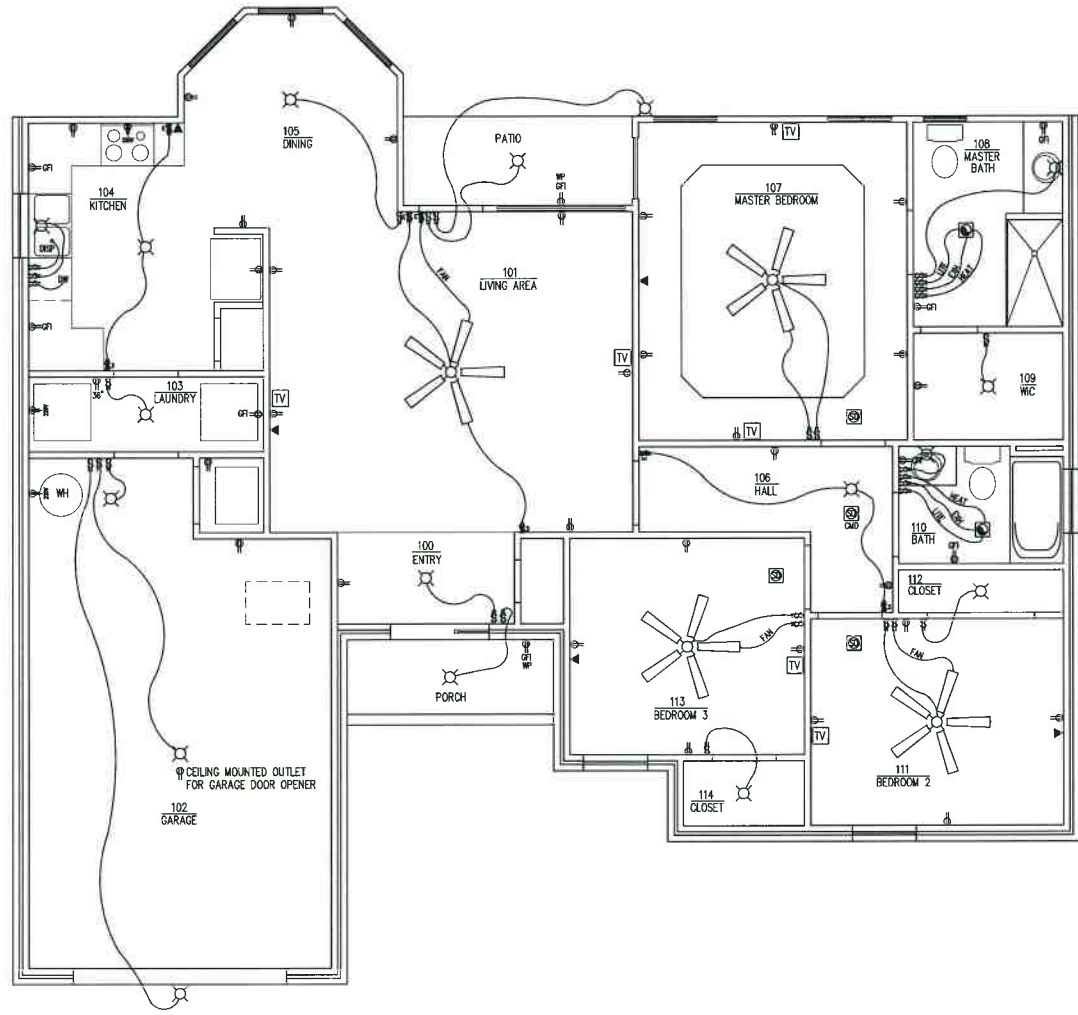

A ELECTRICAL FLOOR PLAN
SCALE: 1/4" = 1'-0"



FORMAT: 24 X 36 SCALE: 48

NEIGHBORHOOD & FAMILY SERVICES
NEW FAMILY HOME
1220 E 24TH STREET
SAN ANGELO, TEXAS

JOB #:	
DATE:	5/18/20
DRAWN BY:	
CHECKED BY:	
REVISIONS:	
FOR REVIEW	

SHEET NO.
A4.0
OF SHEETS